



DRAFT

CONCEPTUAL PUMP
STATION LOCATION
(OPTION 2)

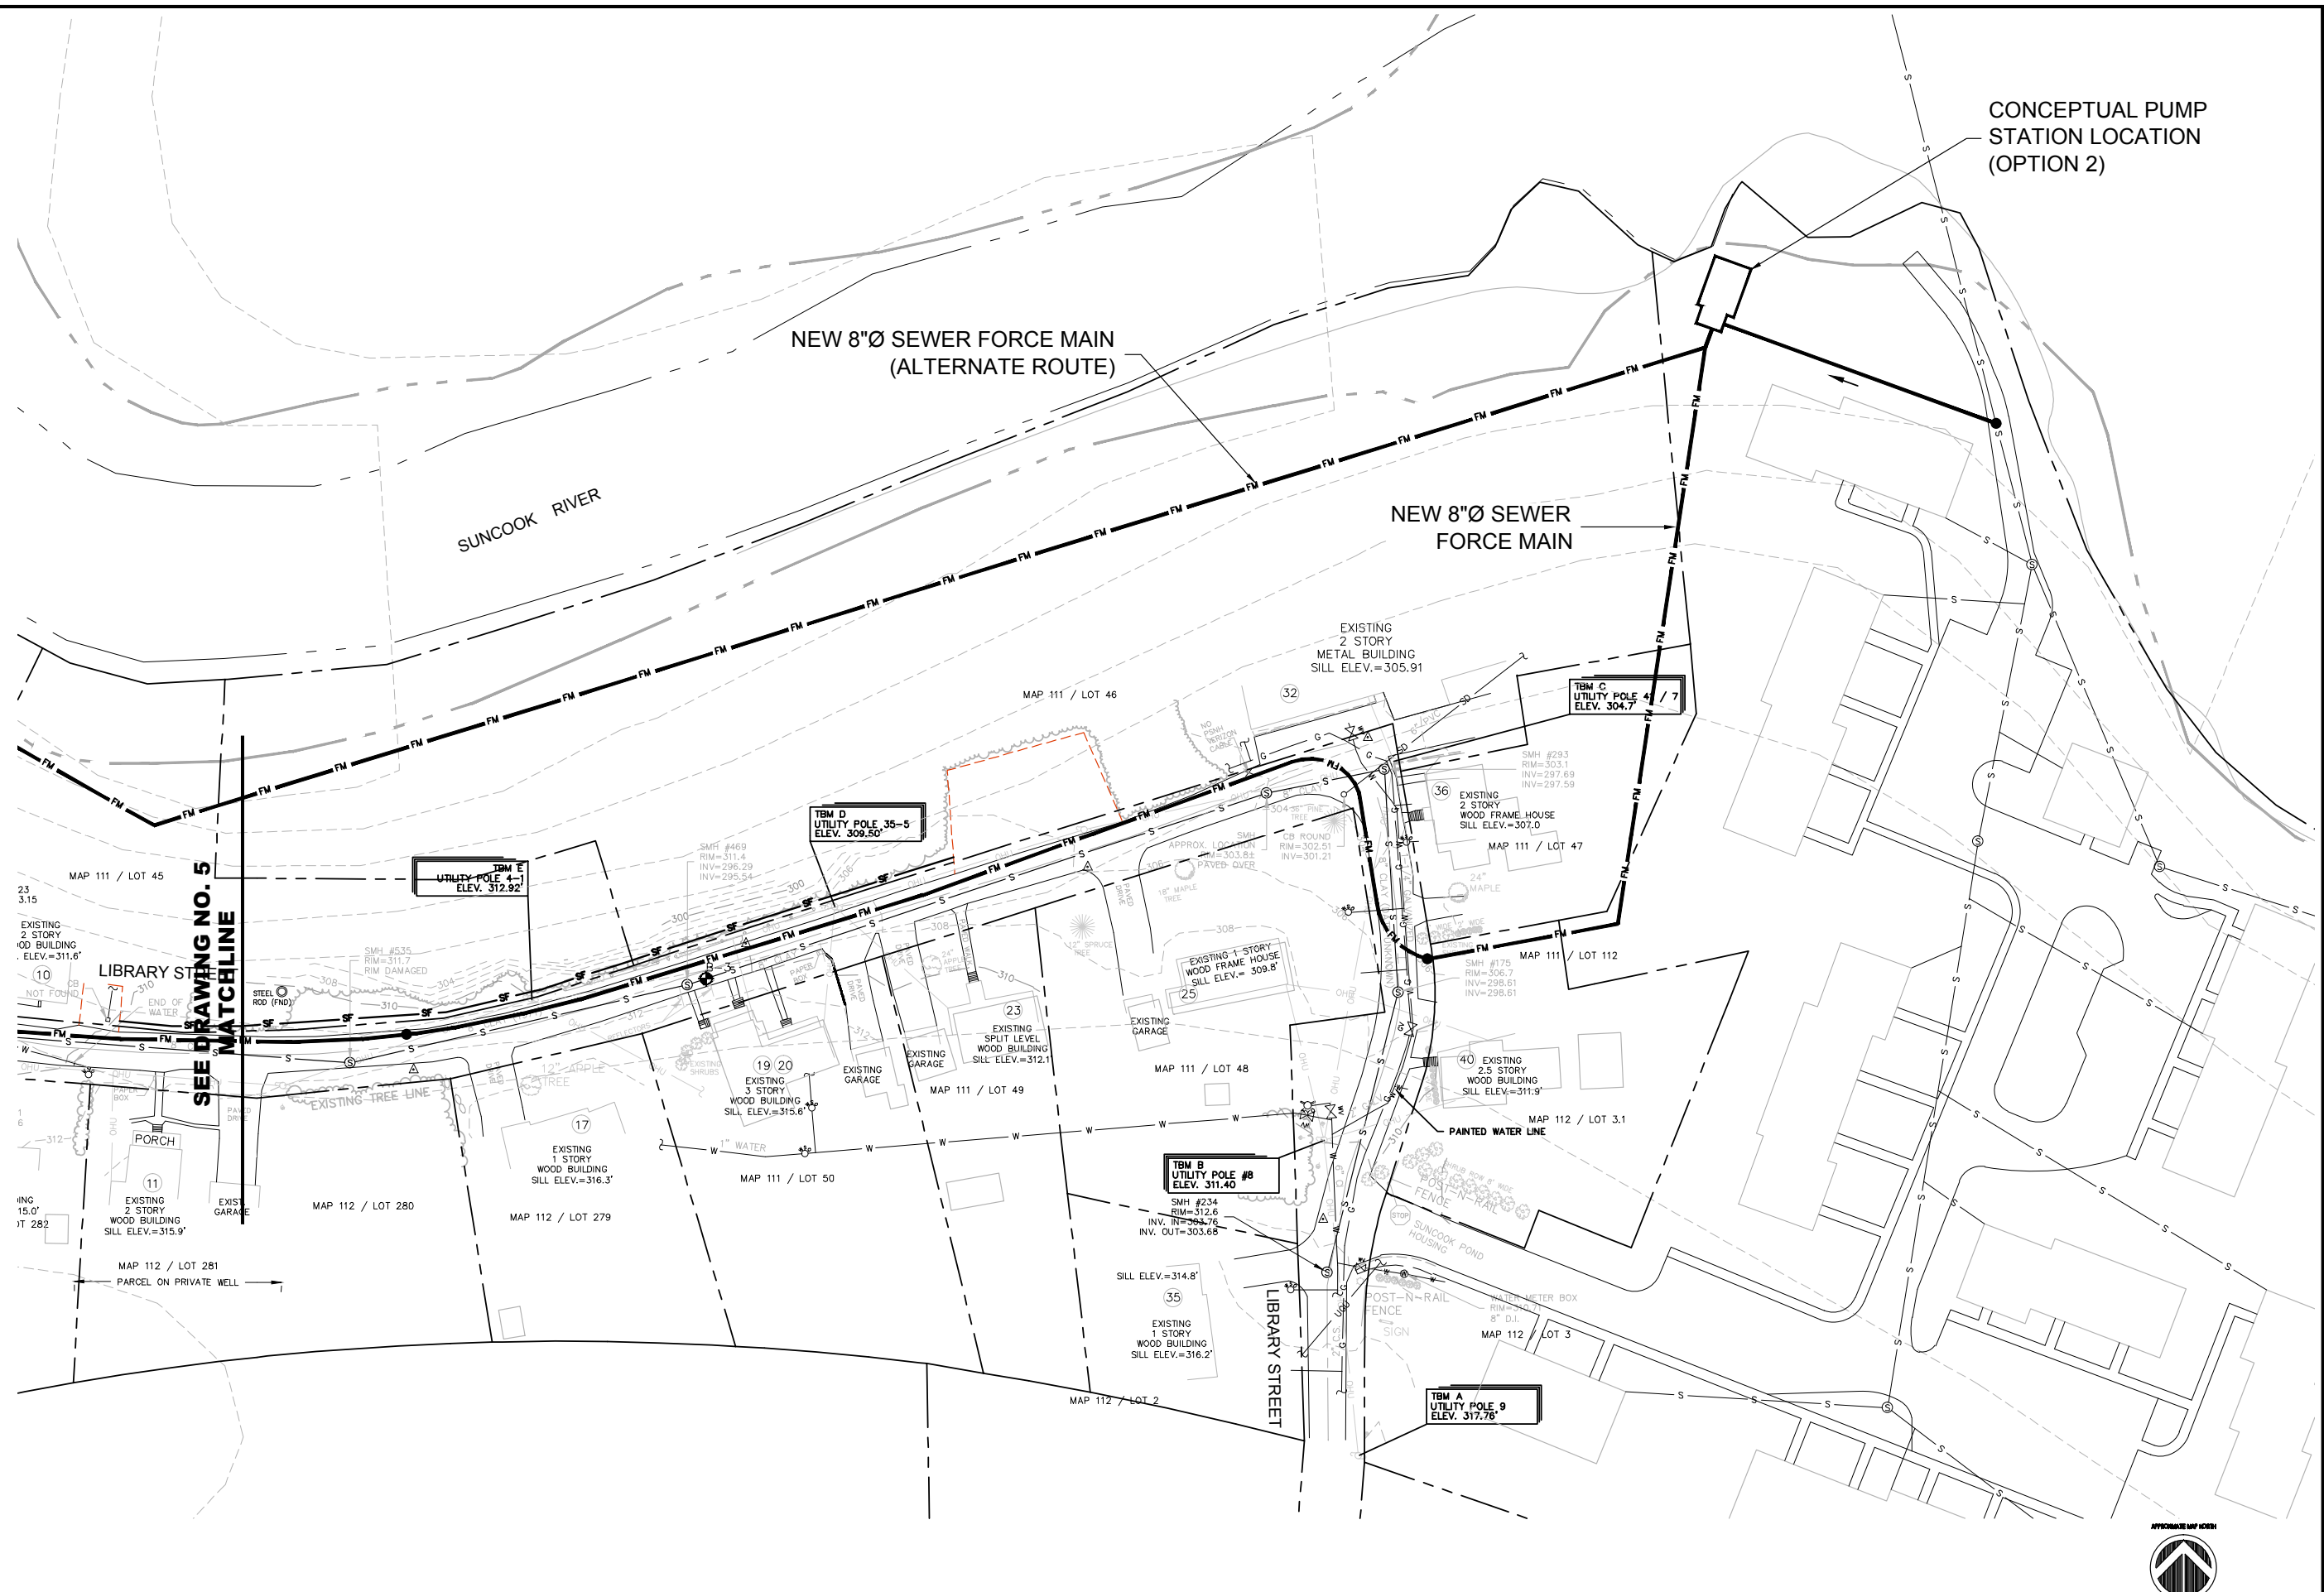

SITE PLAN
SCALE: 1" = 40'

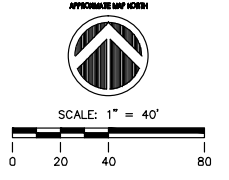

SEE DRAWING NO. 5
MATCHLINE

| DATE | DESCRIPTION | ISSUE |
|------|-------------|-------|
| | | |
| | | |
| | | |
| | | |
| | | |

HOYLE, TANNER
PROJECT NO.
013628
FILE NAME
013628_EH04

THIS DOCUMENT IS PREPARED AS A SERVICE TO THE CLIENT AND SHALL REMAIN THE PROPERTY OF HOYLE, TANNER. IT MAY NOT BE REPRODUCED OR TRANSMITTED IN ANY MANNER OR FOR ANY OTHER PURPOSE, WITHOUT THE WRITTEN PERMISSION OF HOYLE, TANNER.


DESIGNED BY: HEM
DRAWN BY: MAT
CHECKED BY: MAT

Hoyle, Tanner & Associates, Inc.
150 Dow Street, Manchester, NH 03101-1227
Tel (603) 669-5655 Fax (603) 669-4168 Web: www.hoyletanner.com
© Copyright 2015 Hoyle, Tanner & Associates, Inc.

SCALE: AS SHOWN
DATE: OCTOBER 2015


TOWN OF ALLENSTOWN, NEW HAMPSHIRE
SUNCOOK POND PUMP STATION
CONCEPTUAL DESIGN
PUMP STATION & FORCE MAIN
FORCE MAIN PLAN - OPTION 2

DRAWING NO.
4
SHEET OF

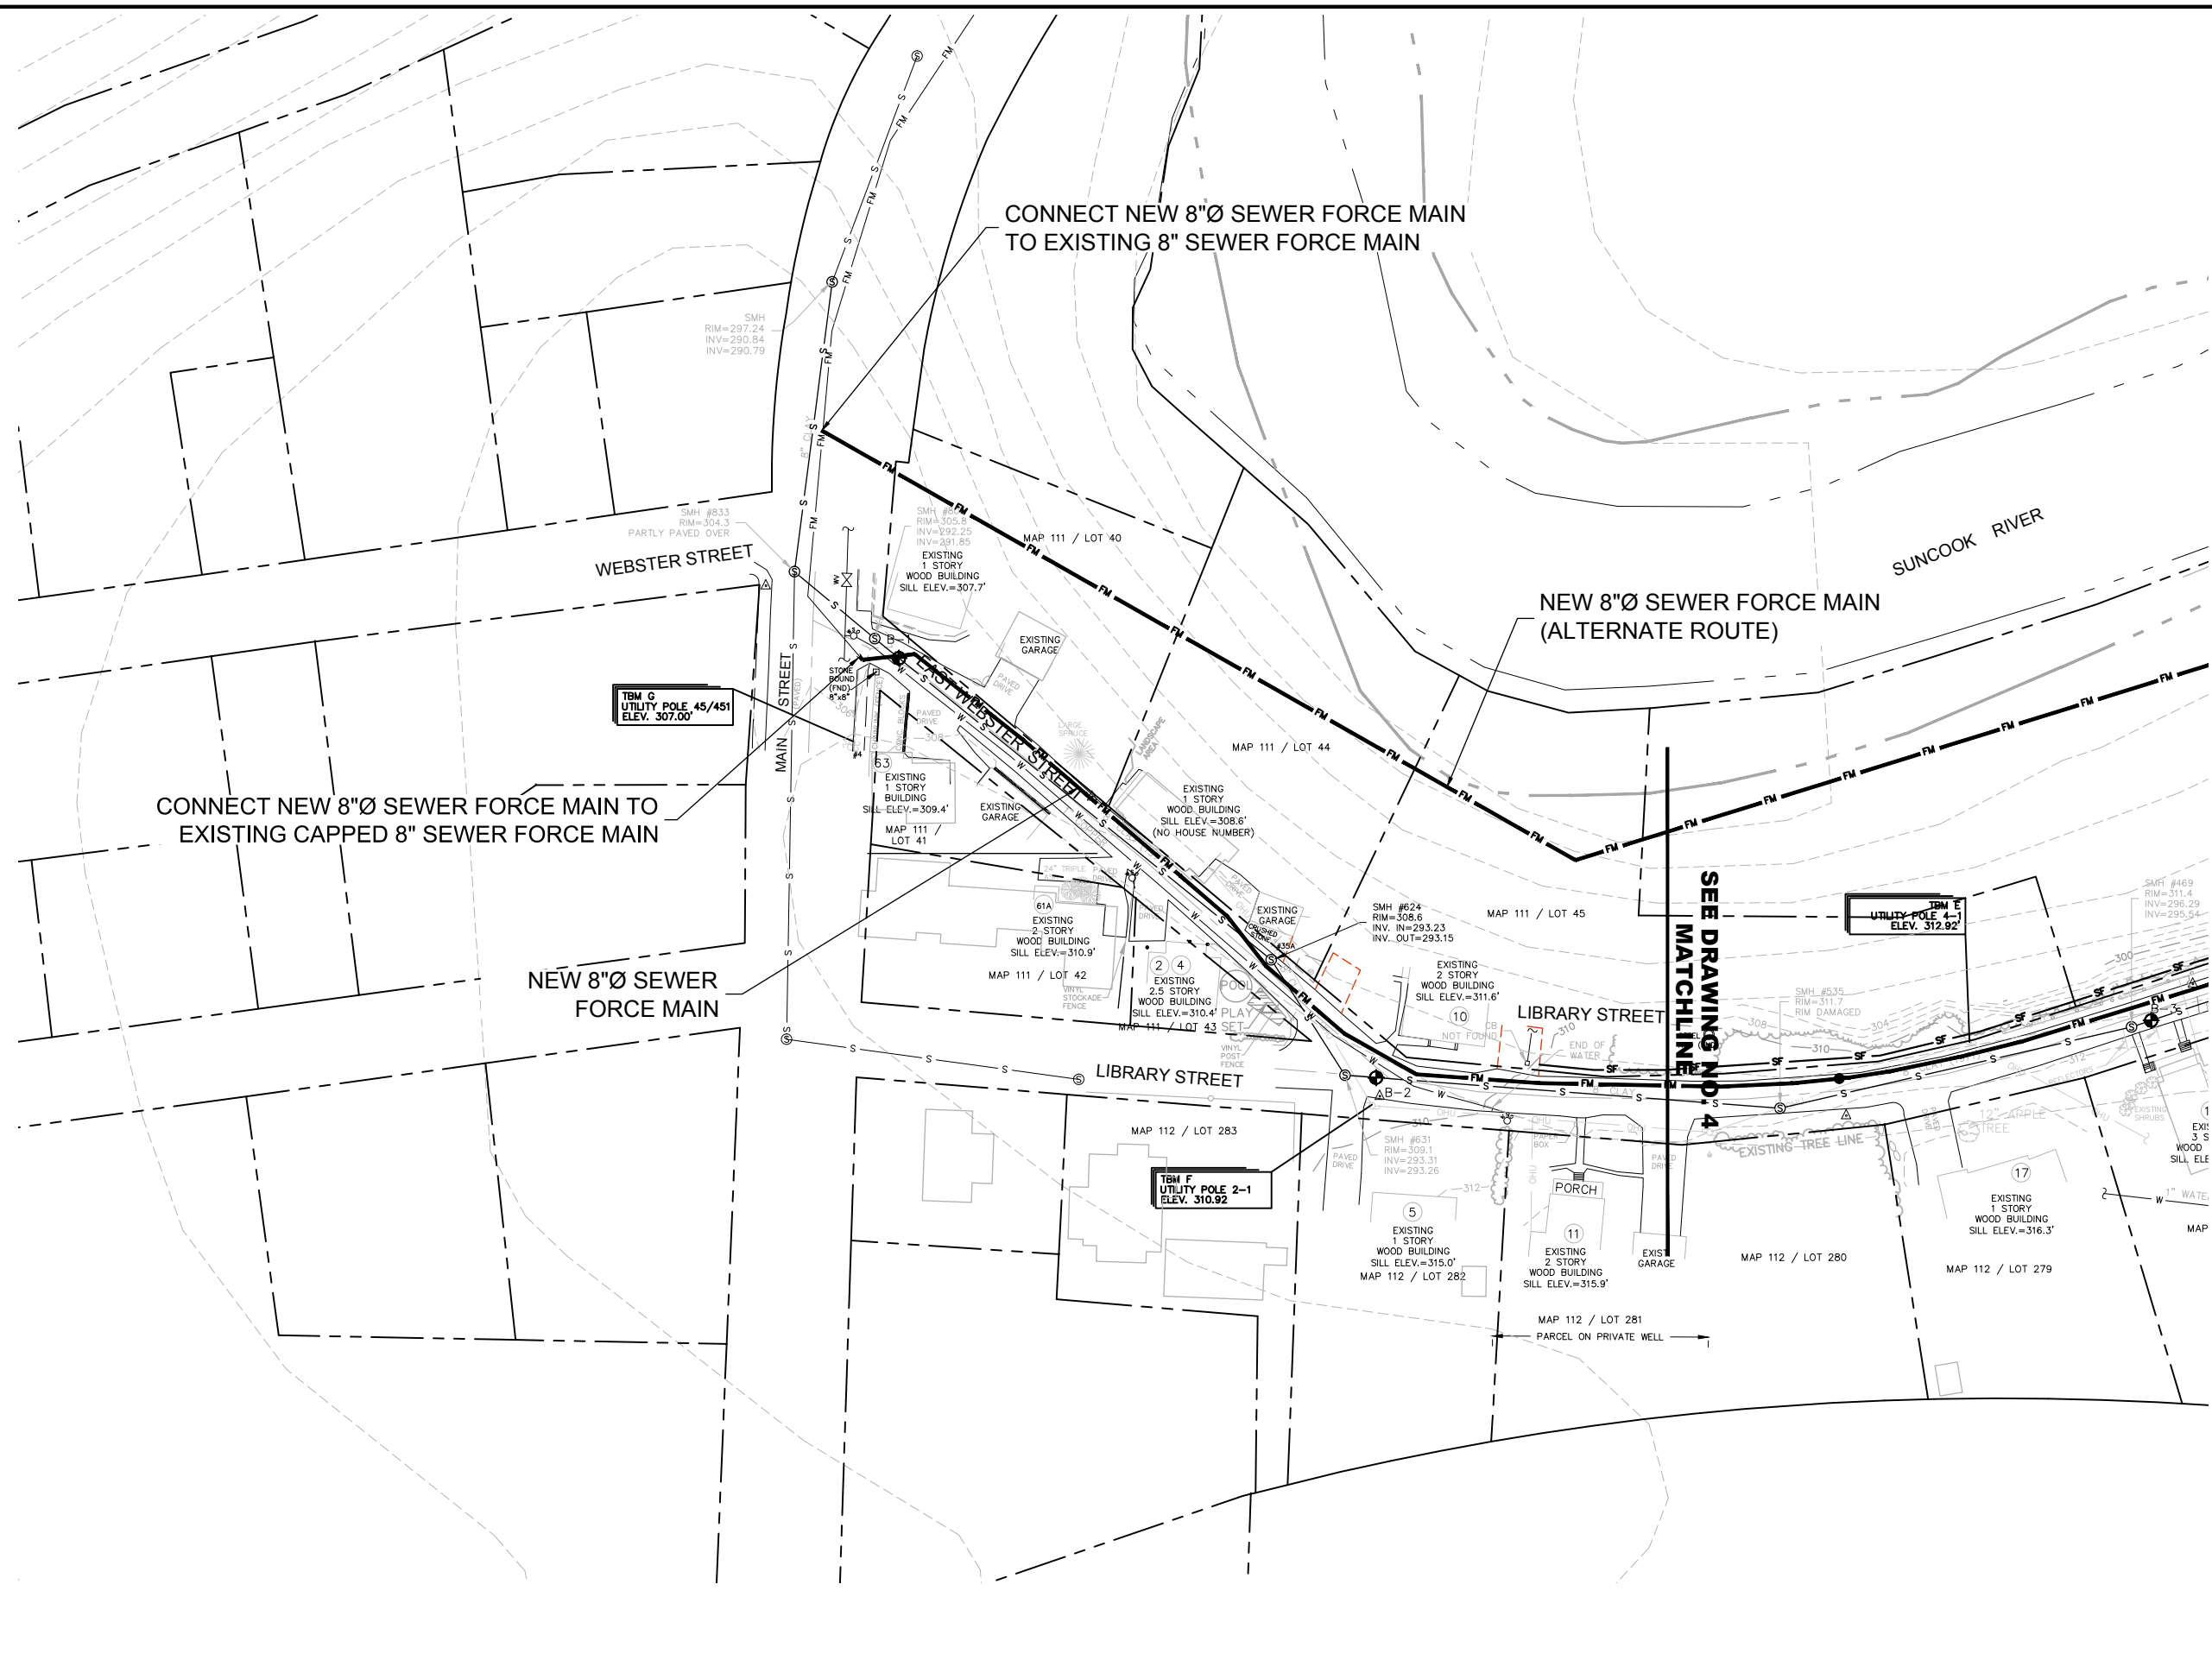

SITE PLAN

 SCALE: 1" = 40'



| NO. | DATE | DESCRIPTION | ISSUE |
|-----|------|-------------|-------|
| | | | |
| | | | |
| | | | |
| | | | |
| | | | |

HOYLE, TANNER
PROJECT NO.
013628
FILE NAME
013628_EH05

THIS DOCUMENT IS PREPARED AS A SERVICE TO THE CLIENT. IT SHALL REMAIN THE PROPERTY OF HOYLE, TANNER. IT MAY NOT BE REPRODUCED OR TRANSMITTED IN ANY MANNER OR FOR ANY OTHER PURPOSE, WITHOUT THE WRITTEN PERMISSION OF HOYLE, TANNER.


DESIGNED BY: HEM
DRAWN BY: MAT

DATE: OCTOBER 2015
SCALE: AS SHOWN

Hoyle, Tanner & Associates, Inc.
150 Dow Street, Manchester, NH 03101-1227
Tel (603) 669-5555 Fax (603) 669-4168 Web: www.hoyletanner.com
© Copyright 2015 Hoyle, Tanner & Associates, Inc.

TOWN OF ALLENSTOWN, NEW HAMPSHIRE
SUNCOOK POND PUMP STATION
CONCEPTUAL DESIGN
PUMP STATION & FORCE MAIN
FORCE MAIN PLAN - OPTION 2

DRAWING NO.
5
SHEET OF

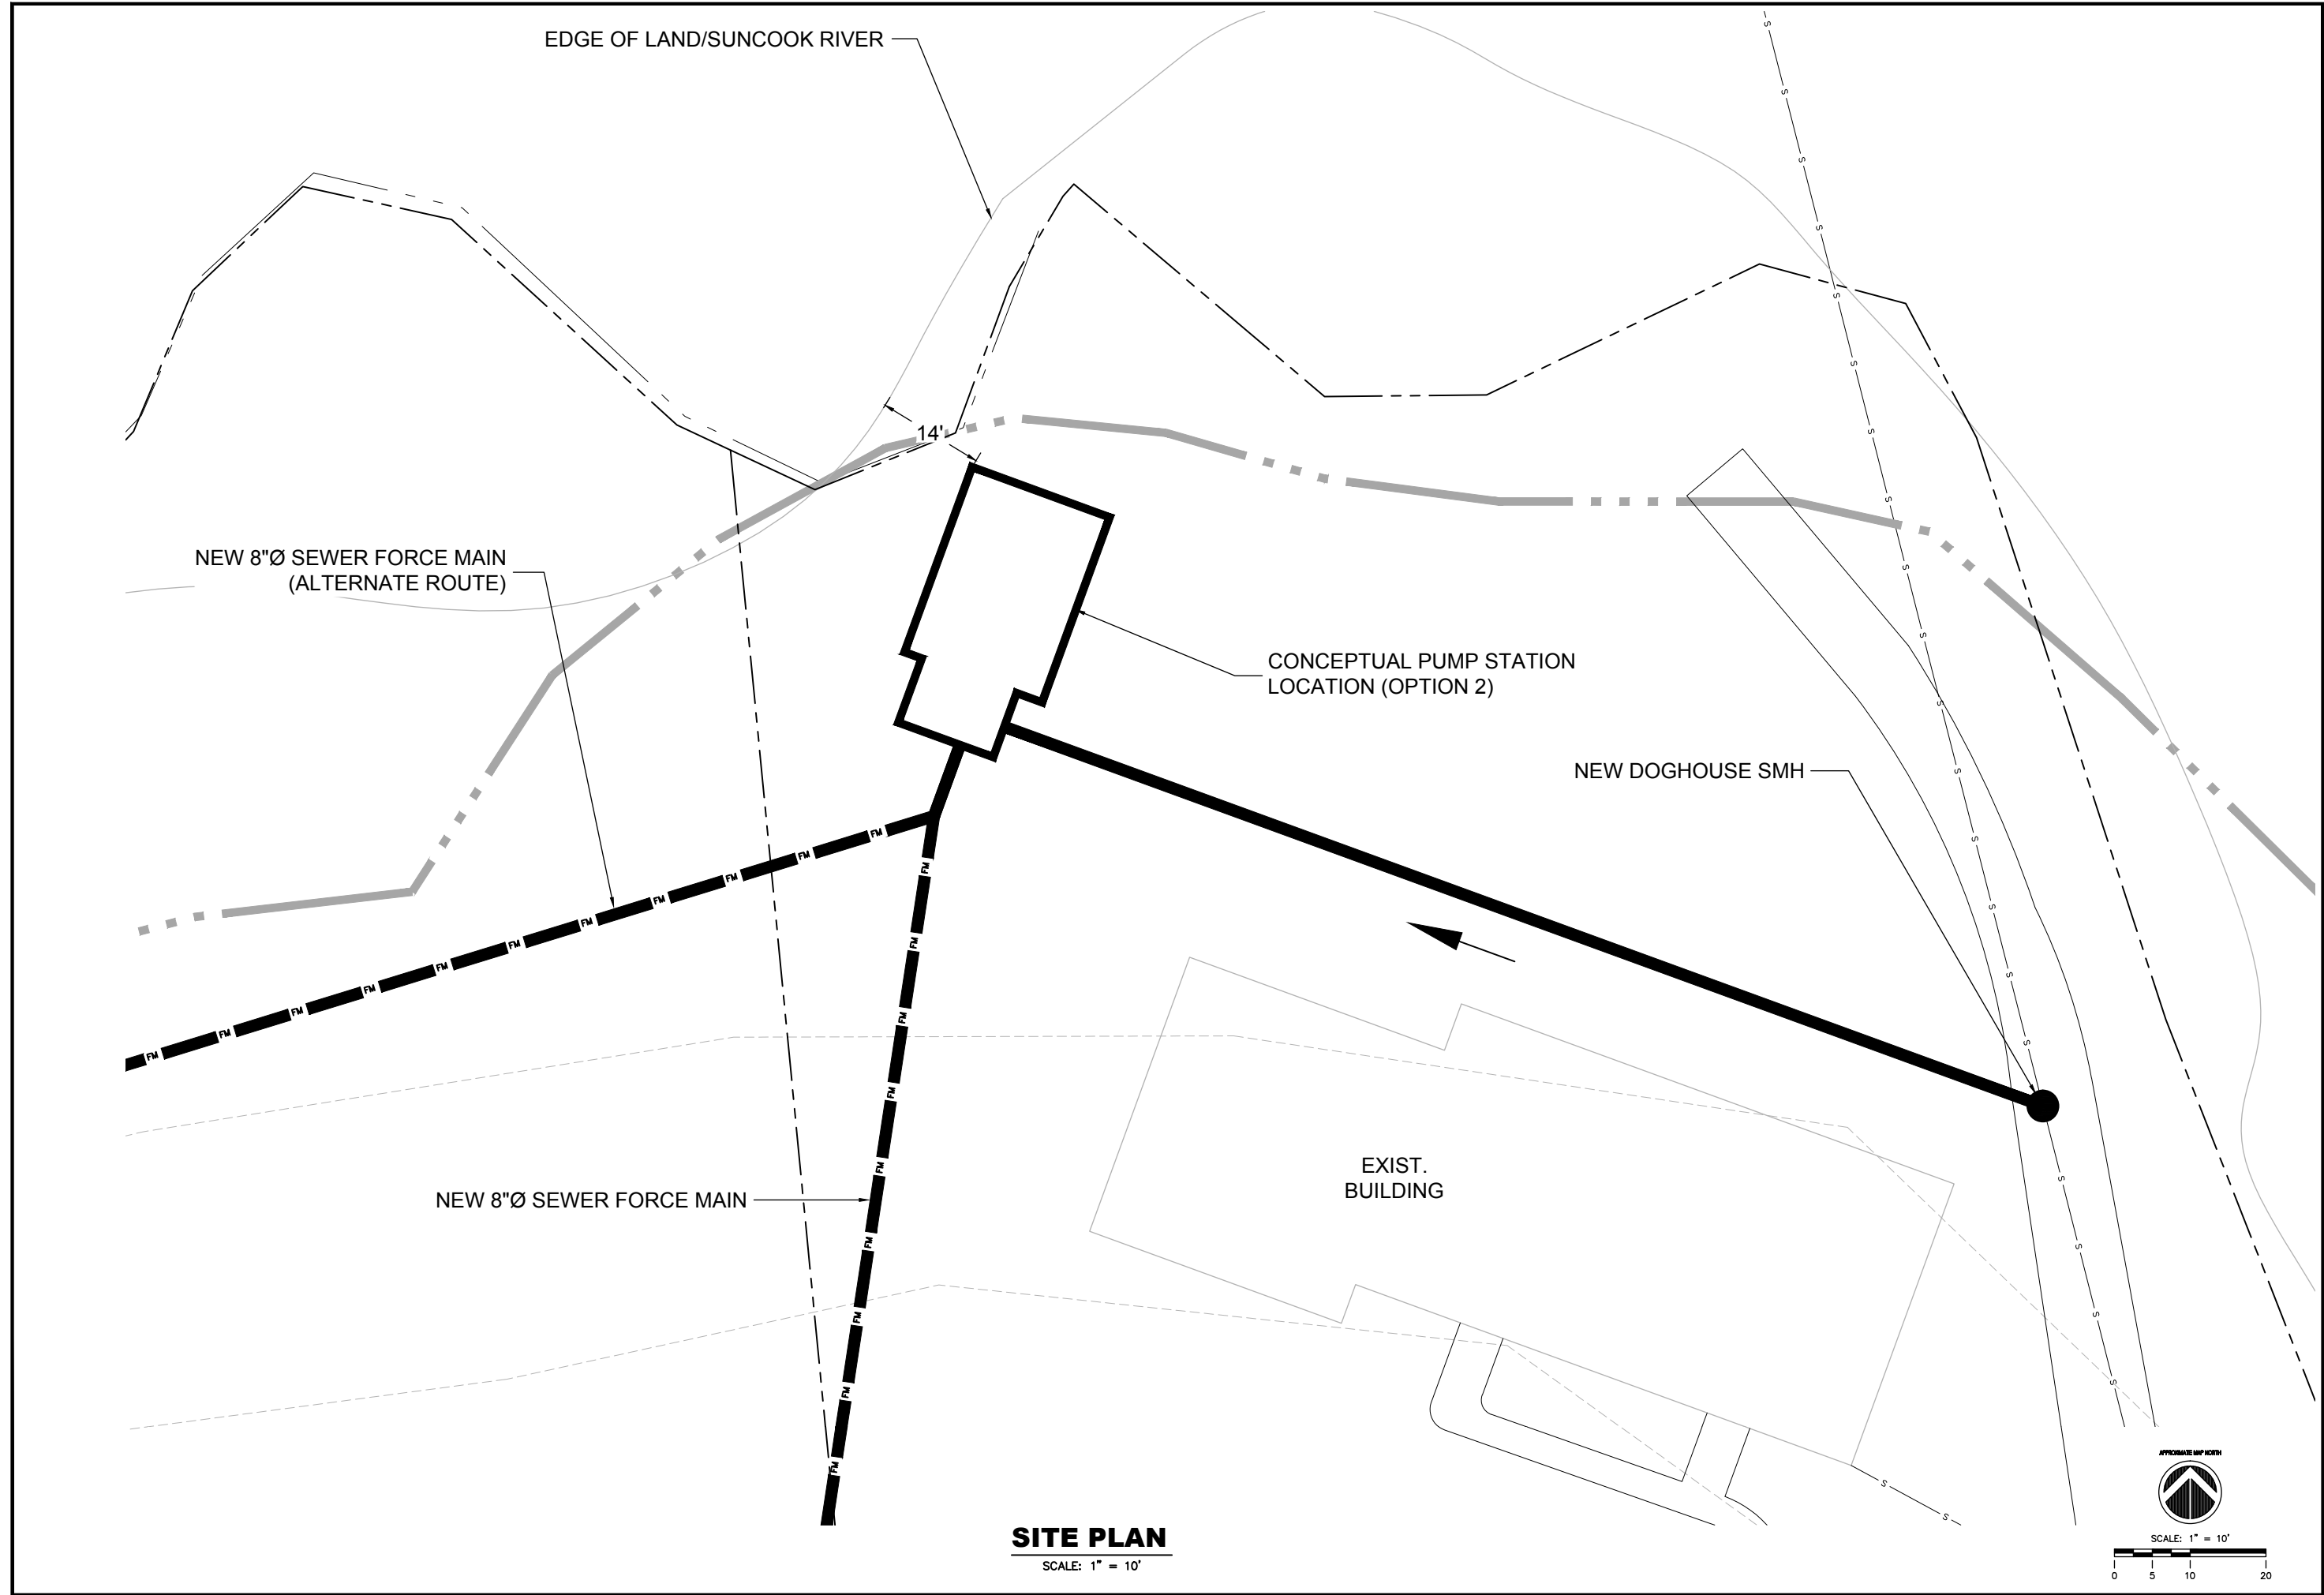

EDGE OF LAND/SUNCOOK RIVER

NEW 8"Ø SEWER FORCE MAIN
(ALTERNATE ROUTE)

CONCEPTUAL PUMP STATION
LOCATION (OPTION 2)

NEW DOGHOUSE SMH


NEW 8"Ø SEWER FORCE MAIN

EXIST.
BUILDING

14'

SITE PLAN

SCALE: 1" = 10'

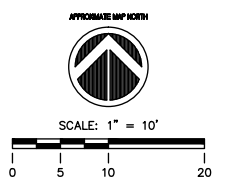

| | |
|--|--------------------------|
| ENGINEER | |
| DRAFT | |
| | DATE |
| | DESCRIPTION |
| | ISSUE |
| HOYLE, TANNER PROJECT NO. 013628 | FILE NAME 013628_EH06 |
| THIS DOCUMENT IS PREPARED AS A CONCEPTUAL DESIGN AND SHALL REMAIN THE PROPERTY OF HOYLE, TANNER. IT MAY NOT BE REPRODUCED, COPIED, OR TRANSMITTED IN ANY MANNER WITHOUT THE WRITTEN PERMISSION OF HOYLE, TANNER. | |
| DESIGNED BY: MAT DRAWN BY: HEM CHECKED BY: MAT | |
| Hoyle, Tanner & Associates, Inc. 150 Dow Street, Manchester, NH 03101-1227 Tel (603) 669-5555 Fax (603) 669-4168 Web: www.hoyletanner.com © Copyright 2015 Hoyle, Tanner & Associates, Inc. | |
| TOWN OF ALLENSTOWN, NEW HAMPSHIRE SUNCOOK POND PUMP STATION | DATE: OCTOBER 2015 |
| CONCEPTUAL DESIGN PUMP STATION & FORCE MAIN SITE PLAN - OPTION 2 | |
| DRAWING NO. | 6 |
| SHEET | OF |