



CONCEPTUAL PUMP STATION LOCATION (OPTION 2)

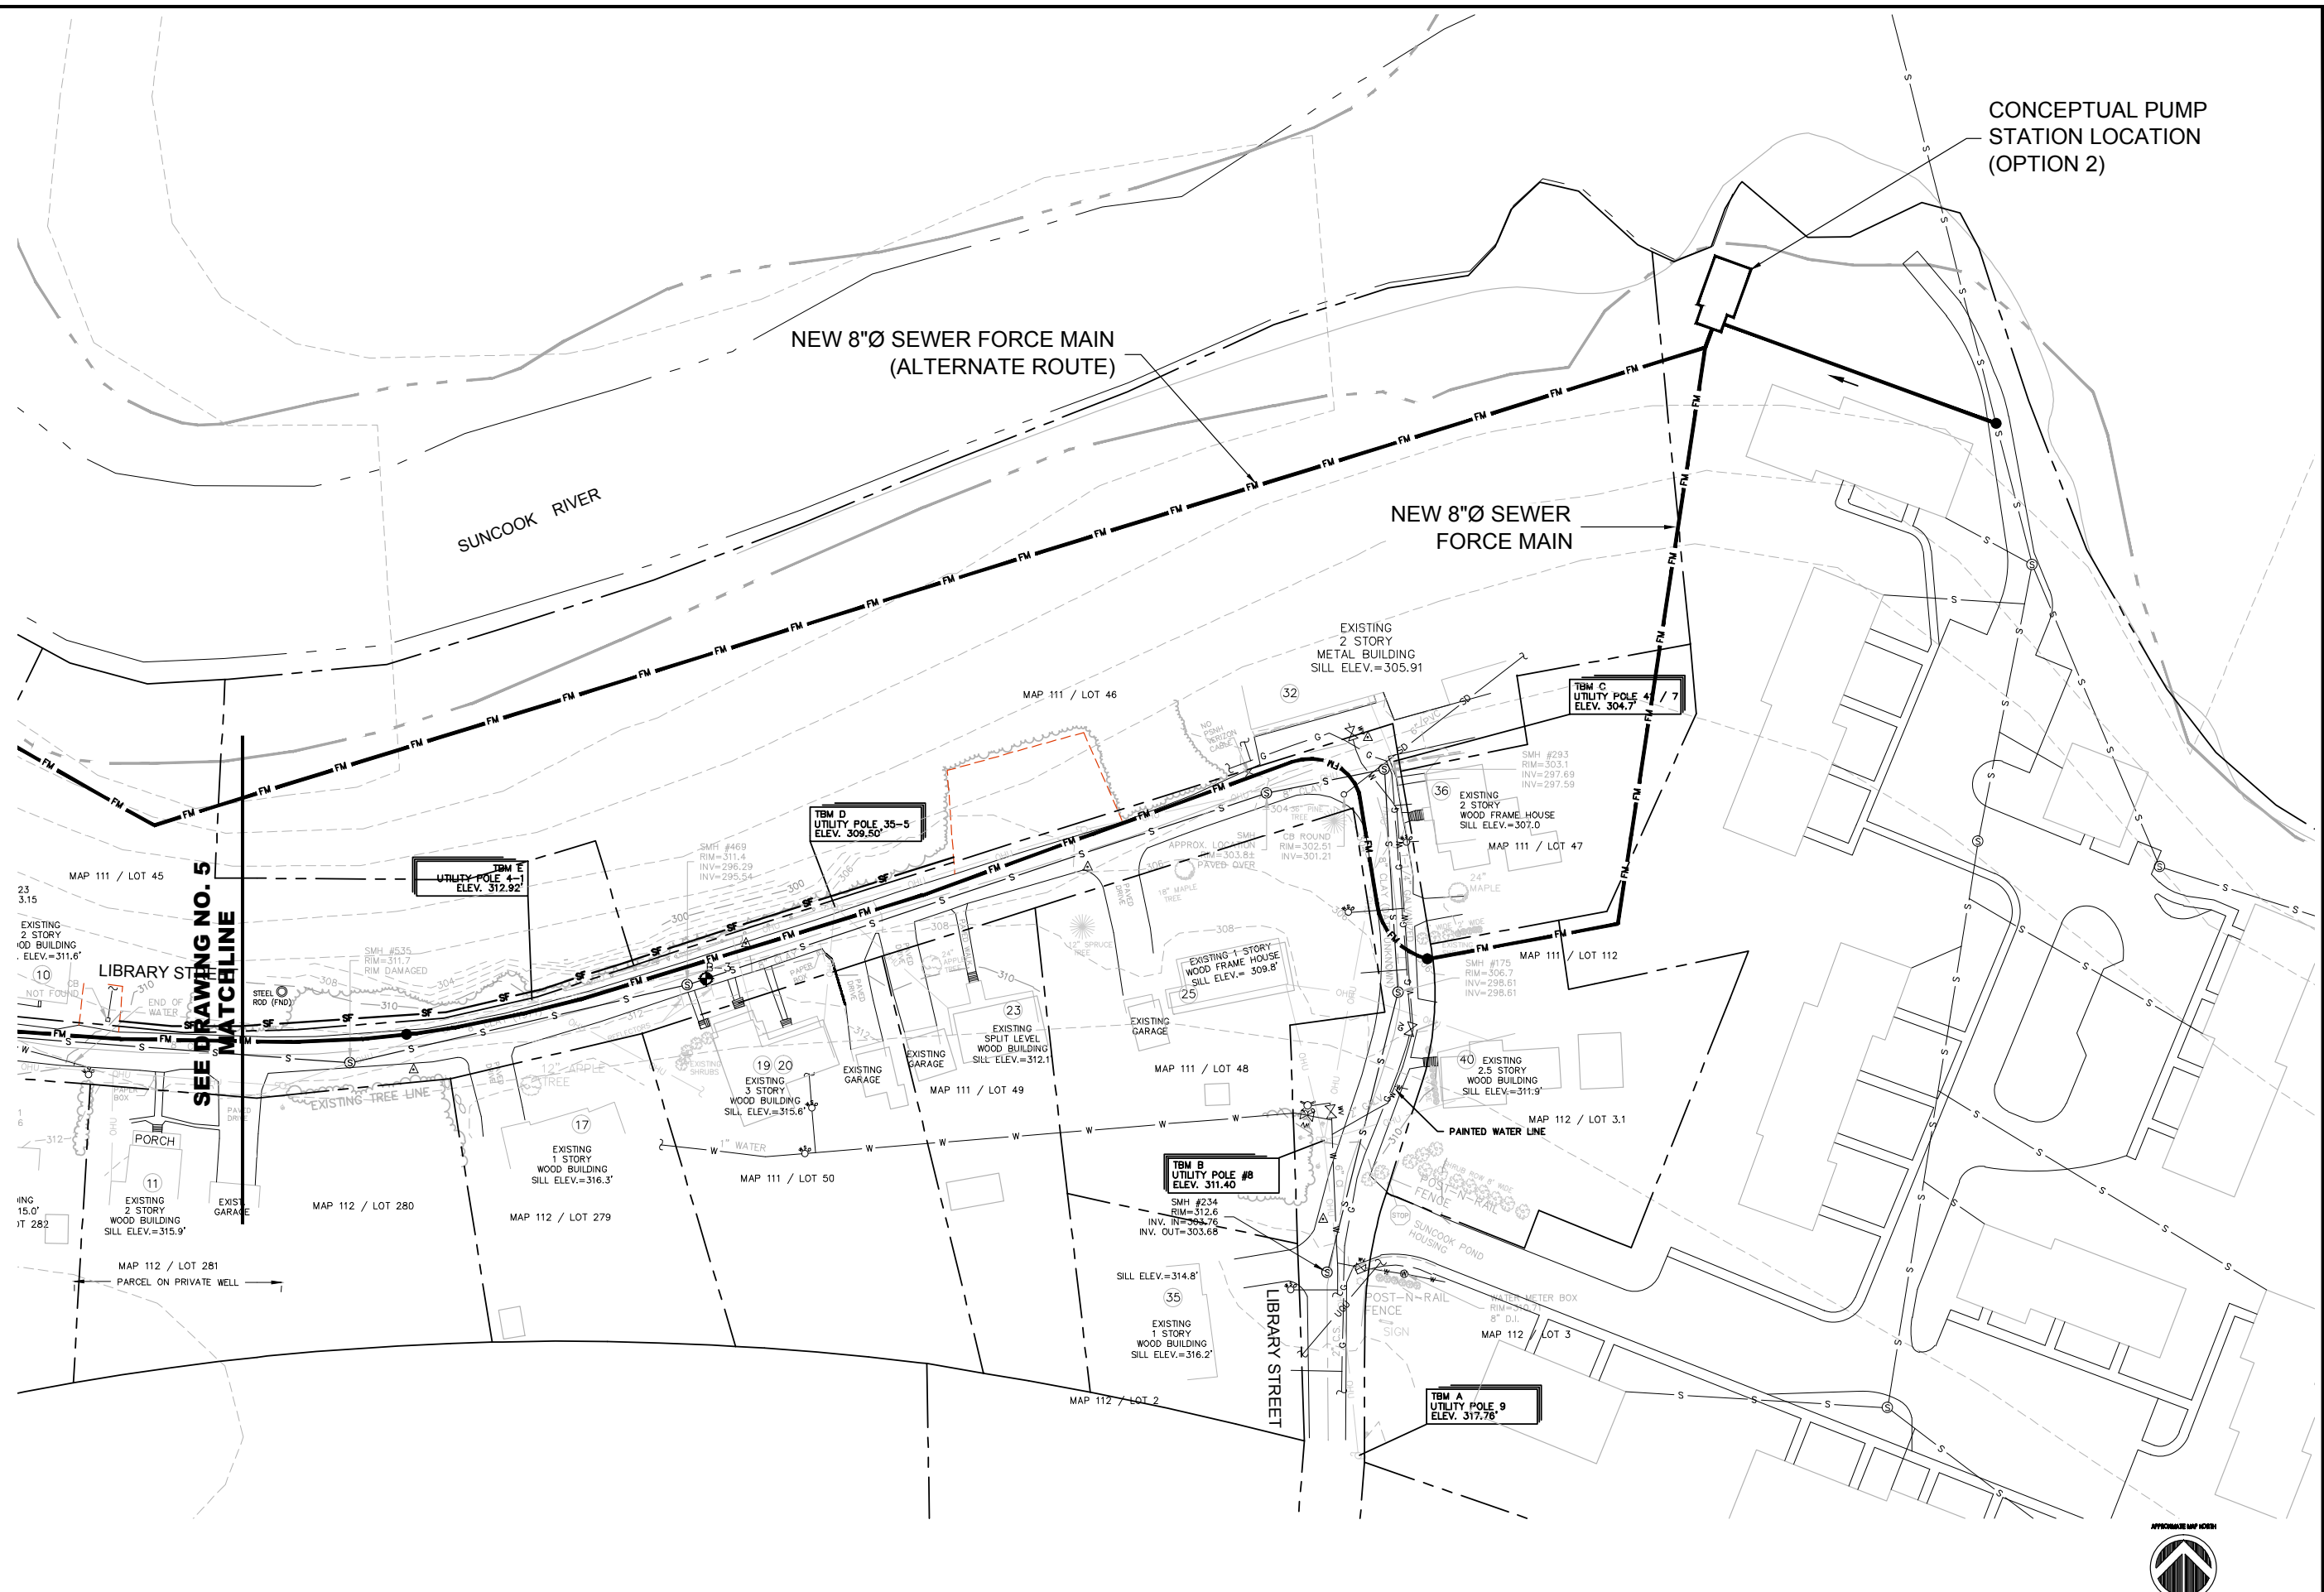

SEE DRAWING NO. 5 MATCHLINE

SITE PLAN  
SCALE: 1" = 40'

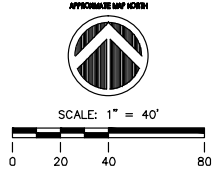

DATE	DESCRIPTION	ISSUE

HOYLE, TANNER  
PROJECT NO.  
013628  
FILE NAME  
013628\_EH04

THIS DOCUMENT IS PREPARED AS A SERVICE TO THE CLIENT. IT SHALL REMAIN THE PROPERTY OF HOYLE, TANNER. IT MAY NOT BE REPRODUCED OR TRANSMITTED IN ANY MANNER OR FOR ANY OTHER PURPOSE, WITHOUT THE WRITTEN PERMISSION OF HOYLE, TANNER.

DESIGNED BY: MAT  
DRAWN BY: HEM  
CHECKED BY: MAT

Hoyle, Tanner & Associates, Inc.  
150 Dow Street, Manchester, NH 03101-1227  
Tel (603) 669-5655 Fax (603) 669-4168 Web: www.hoyletanner.com  
© Copyright 2015 Hoyle, Tanner & Associates, Inc.

SCALE: AS SHOWN  
DATE: OCTOBER 2015

TOWN OF ALLENSTOWN, NEW HAMPSHIRE  
SUNCOOK POND PUMP STATION  
CONCEPTUAL DESIGN  
PUMP STATION & FORCE MAIN  
FORCE MAIN PLAN - OPTION 2

DRAWING NO.  
4  
SHEET OF

DATE	DESCRIPTION	ISSUE

HOYLE, TANNER  
PROJECT NO.  
**013628**  
FILE NAME  
013628\_EH05

THIS DOCUMENT IS PREPARED AS A CONCEPTUAL DESIGN AND SHALL REMAIN THE PROPERTY OF HOYLE, TANNER. IT MAY NOT BE REPRODUCED, COPIED, OR TRANSMITTED IN ANY MANNER WITHOUT THE WRITTEN PERMISSION OF HOYLE, TANNER.


DESIGNED BY: HEM  
DRAWN BY: MAT  
CHECKED BY: MAT

**Hoyle, Tanner & Associates, Inc.**  
150 Dow Street, Manchester, NH 03101-1227  
Tel (603) 669-5555 Fax (603) 669-4168 Web: www.hoyletanner.com  
© Copyright 2015 Hoyle, Tanner & Associates, Inc.


SCALE: AS SHOWN  
DATE: OCTOBER 2015


TOWN OF ALLENSTOWN, NEW HAMPSHIRE  
SUNCOOK POND PUMP STATION  
CONCEPTUAL DESIGN  
PUMP STATION & FORCE MAIN  
FORCE MAIN PLAN - OPTION 2

DRAWING NO.  
**5**  
SHEET OF

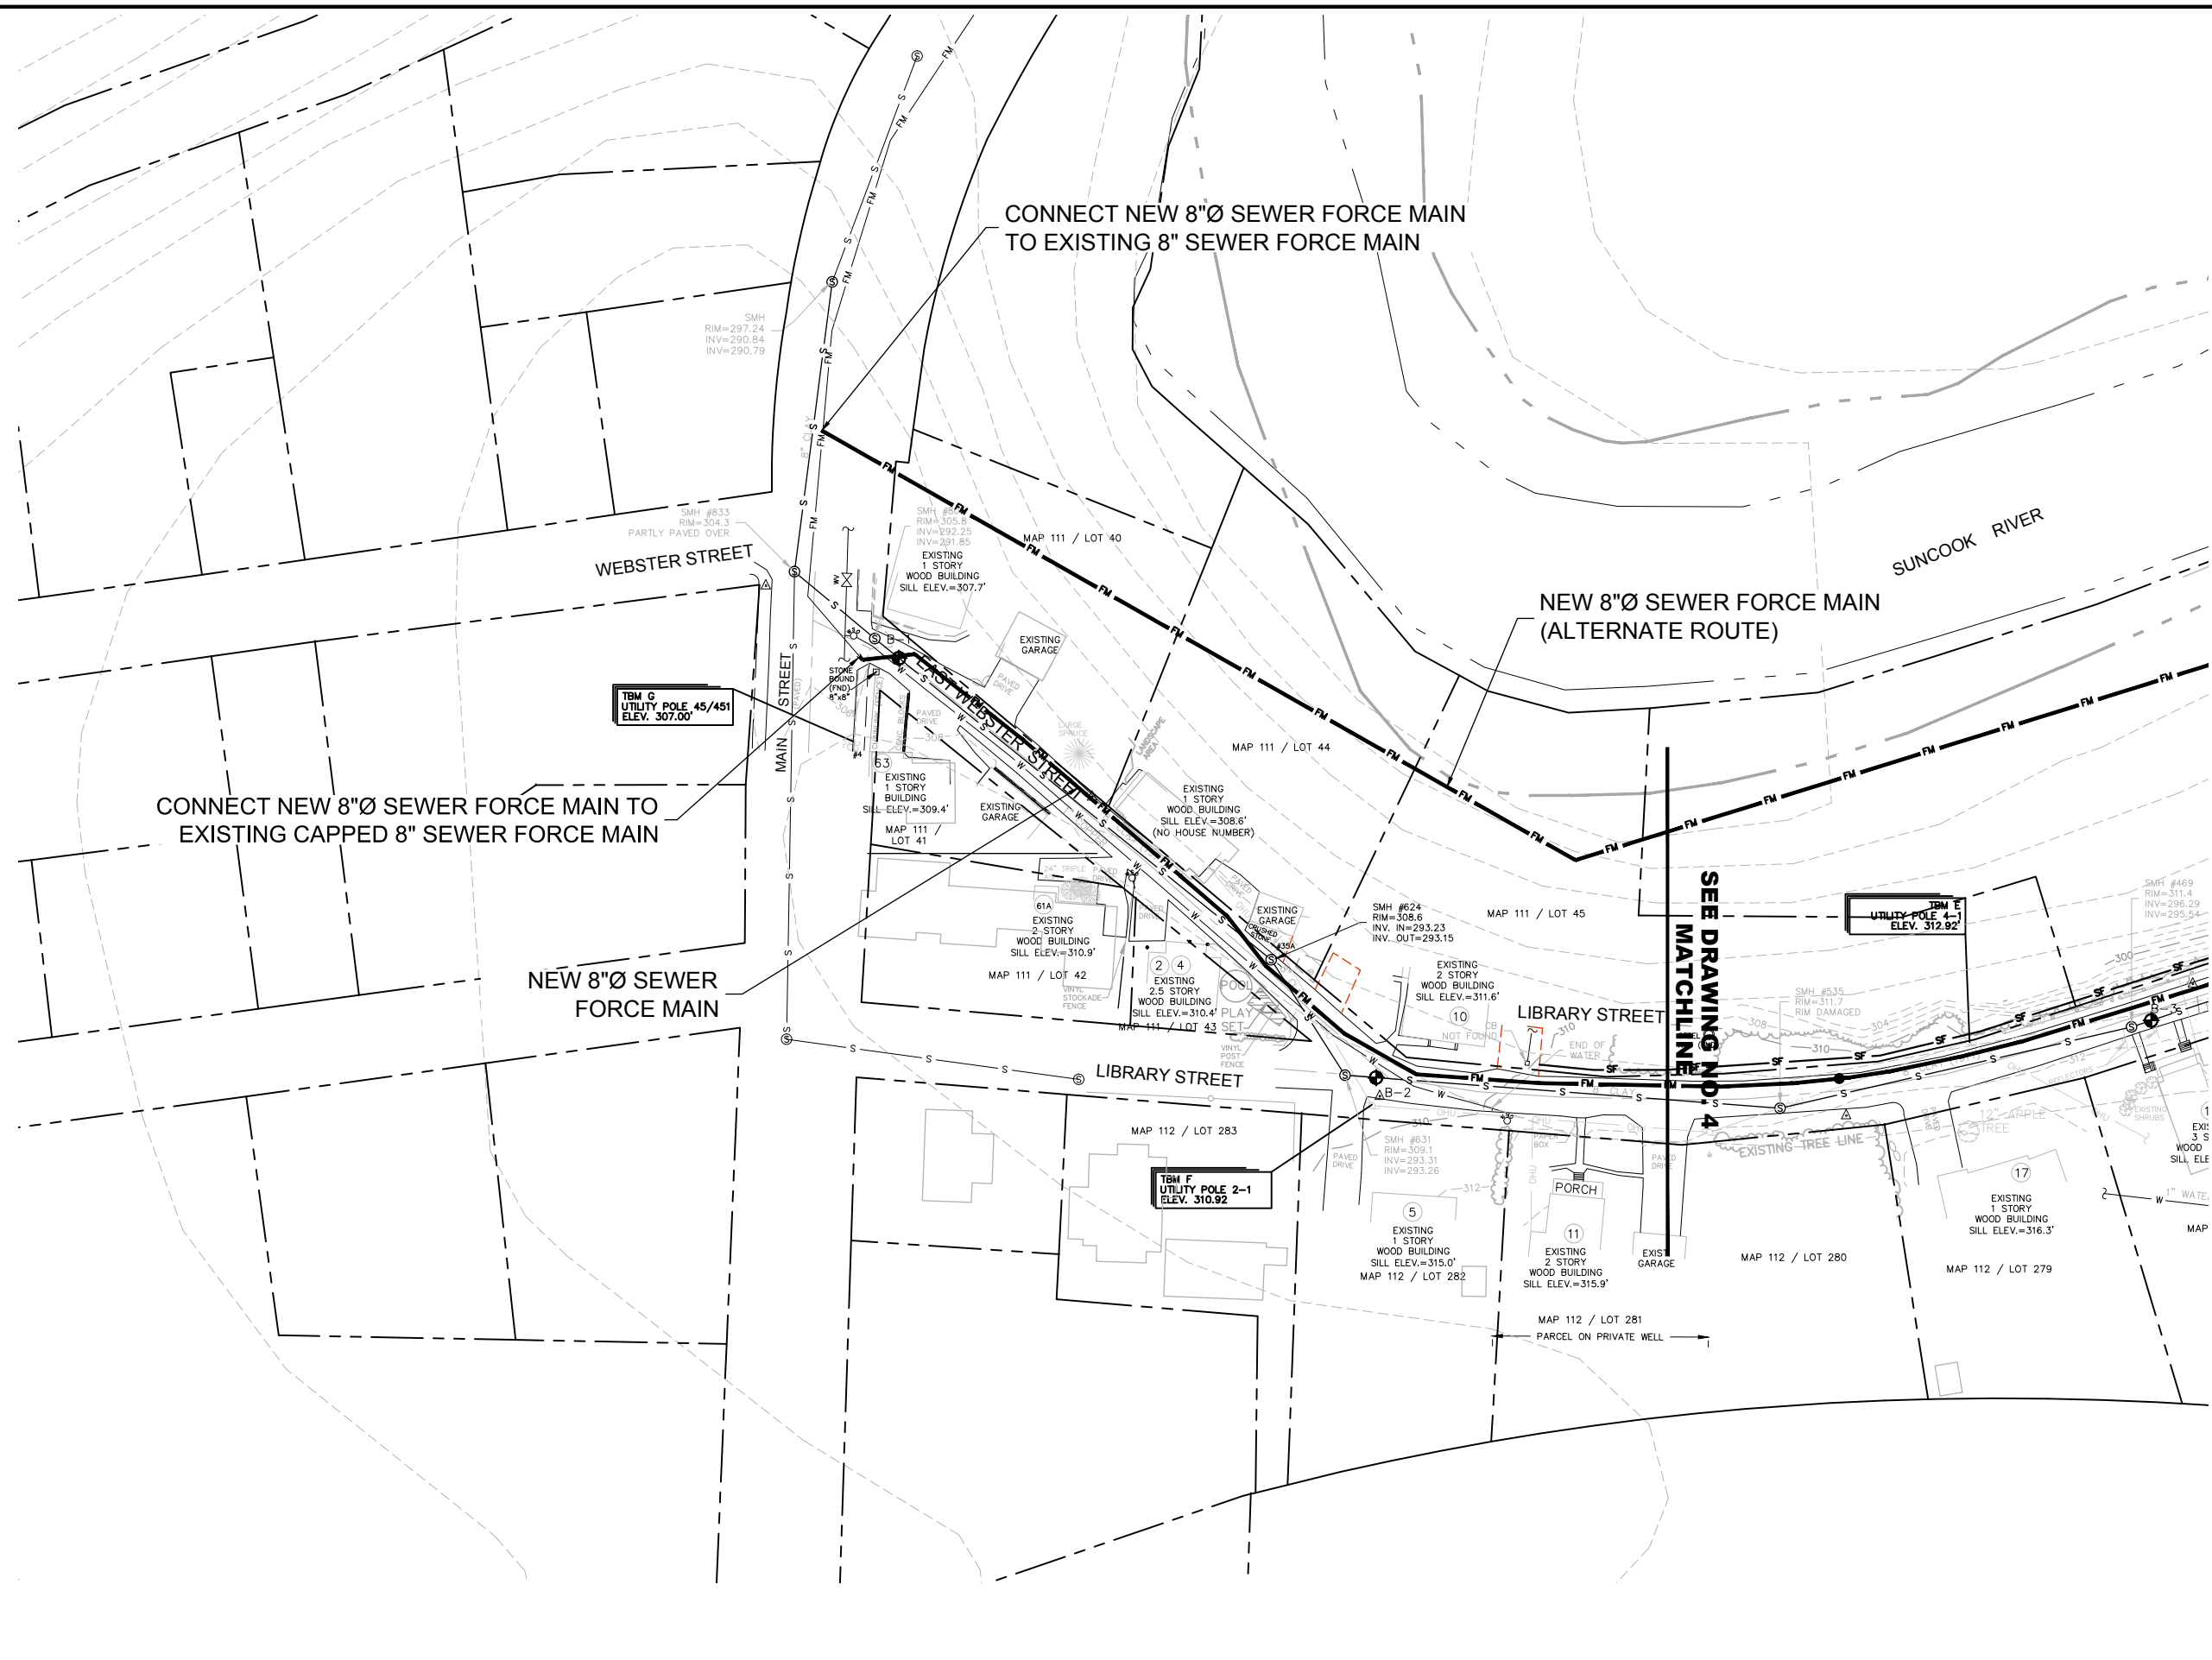


**SITE PLAN**  
SCALE: 1" = 40'

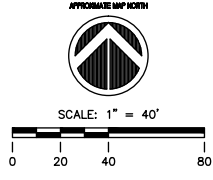

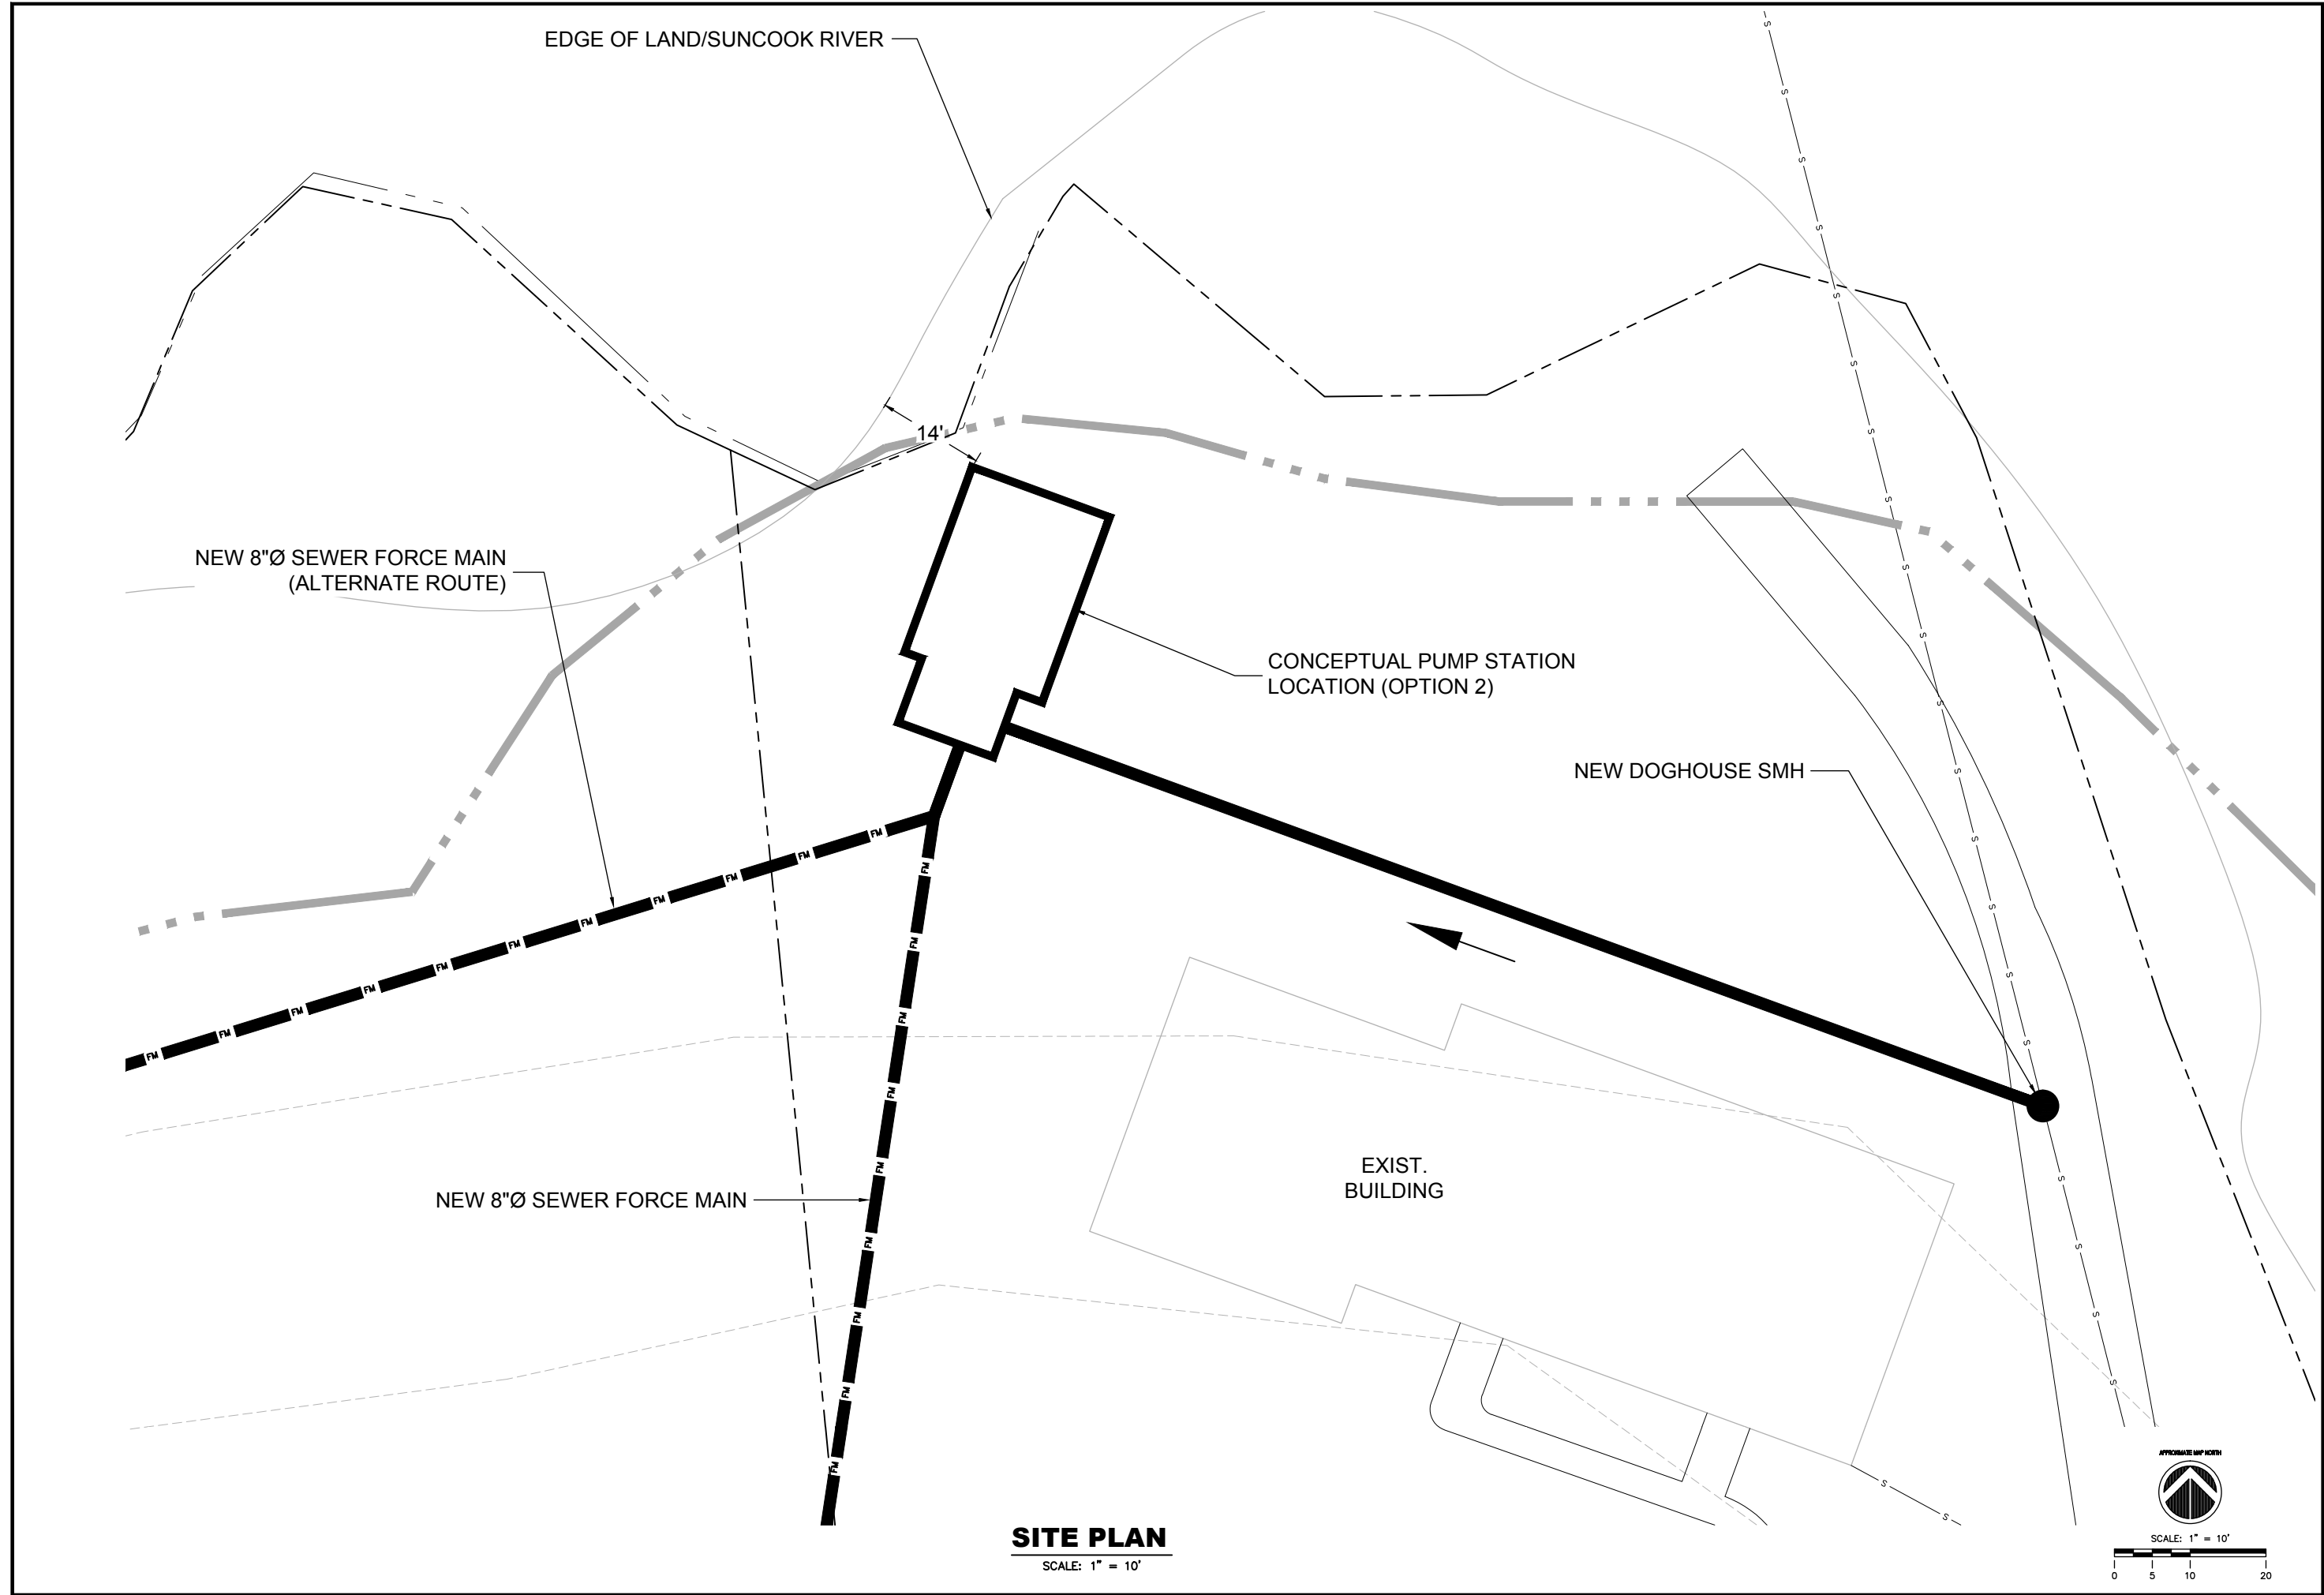

**SITE PLAN**  
SCALE: 1" = 10'

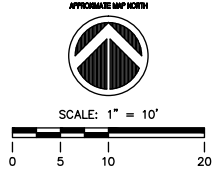

ENGINEER	
DRAFT	
	DATE
	DESCRIPTION
	ISSUE
HOYLE, TANNER PROJECT NO. 013628	FILE NAME 013628_EH06
THIS DOCUMENT IS PREPARED AS A SERVICE TO THE CLIENT AND SHALL REMAIN THE PROPERTY OF HOYLE, TANNER. IT MAY NOT BE REPRODUCED, COPIED, OR TRANSMITTED IN ANY MANNER OR BY ANY MEANS, INCLUDING ELECTRONICALLY, FOR ANY OTHER PURPOSE THAN THAT AUTHORIZED BY HOYLE, TANNER. PERMISSION OF HOYLE, TANNER.	
DRAWN BY	CHECKED BY
HEM	MAT
DESIGNED BY	DATE
MAY	OCTOBER 2015
Hoyle, Tanner & Associates, Inc.	
150 Dow Street, Manchester, NH 03101-1227 Tel (603) 669-5555 Fax (603) 669-4168 Web: www.hoyletanner.com © Copyright 2015 Hoyle, Tanner & Associates, Inc.	
TOWN OF ALLENSTOWN, NEW HAMPSHIRE SUNCOOK POND PUMP STATION	SCALE: AS SHOWN
CONCEPTUAL DESIGN PUMP STATION & FORCE MAIN SITE PLAN - OPTION 2	
DRAWING NO.	
6	
SHEET	OF